


SINGLE LINE DIAGRAM

SCALE

NTC

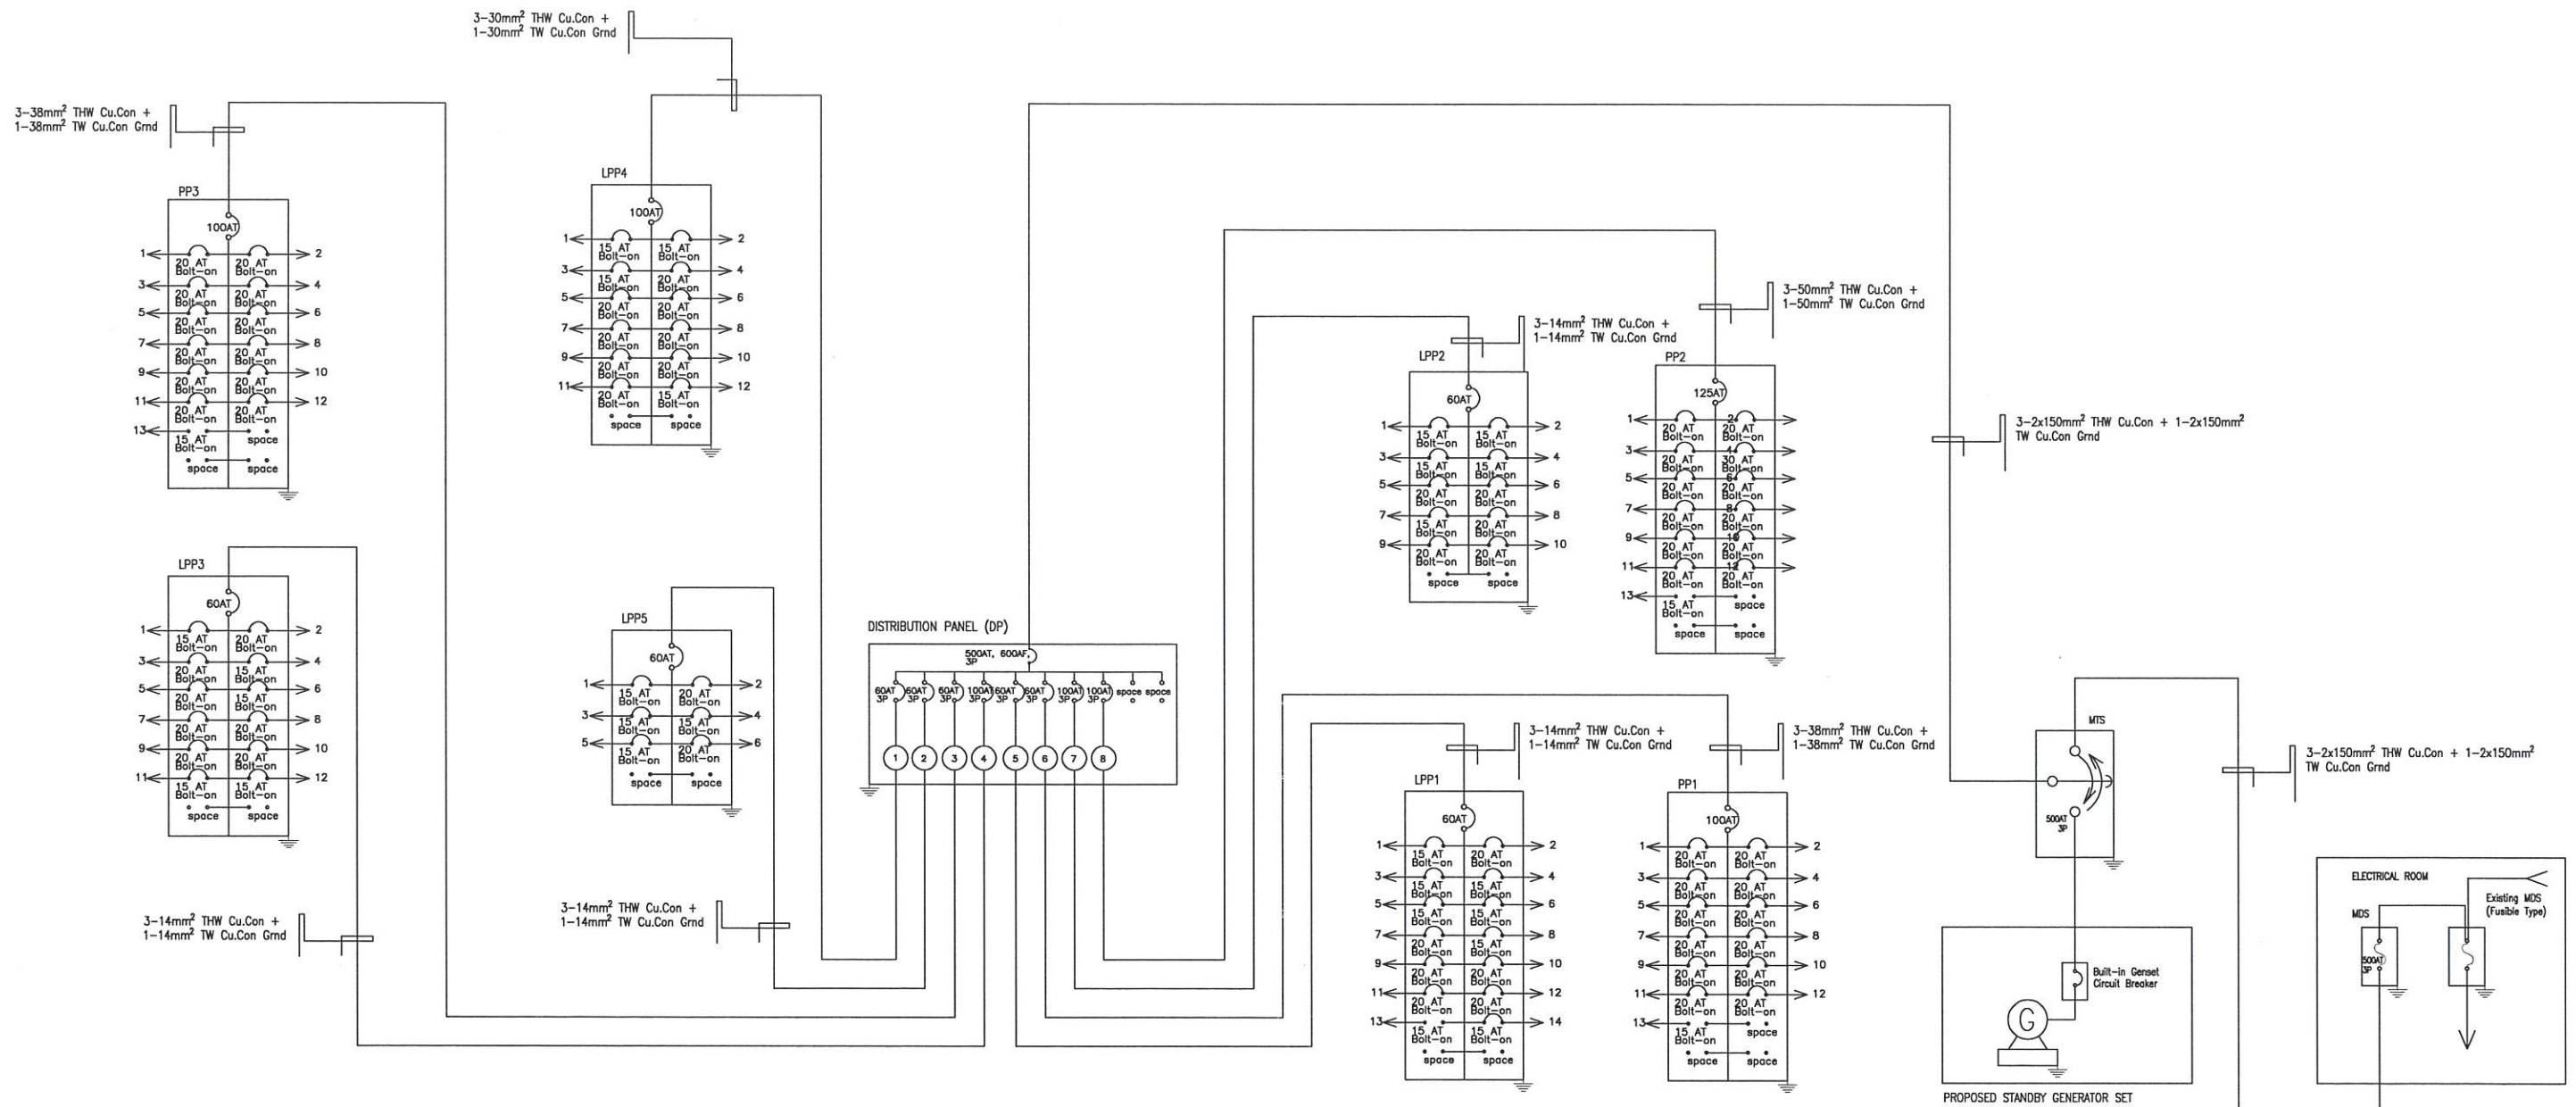

PHILIPPINE COAST GUARD

HEADQUARTERS PHILIPPINE COAST GUARD
139 25TH ST. PORT AREA MANILA

COAST GUARD INFRASTRUCTURE
DEVELOPMENT SERVICE

PROJECT TITLE : REWIRING / UPGRADING OF CGAG ELECTRICAL SYSTEM
LOCATION : DOTC Hangar Domestic Airport Complex, Pasay City
OWNER : PHILIPPINE COAST GUARD

PREPARED BY:

CHECKED BY:

RECOMMENDED BY:

APPROVED BY:

REVISION

DATE


REVALIDATION

19 MAR '19

HILARIO A. ADAYA, REE
Engineer IV, CGIDS

CDR/AUREL PAUL N. MARIANO JR PCG
Commander, CGIDS

SHEET NO.

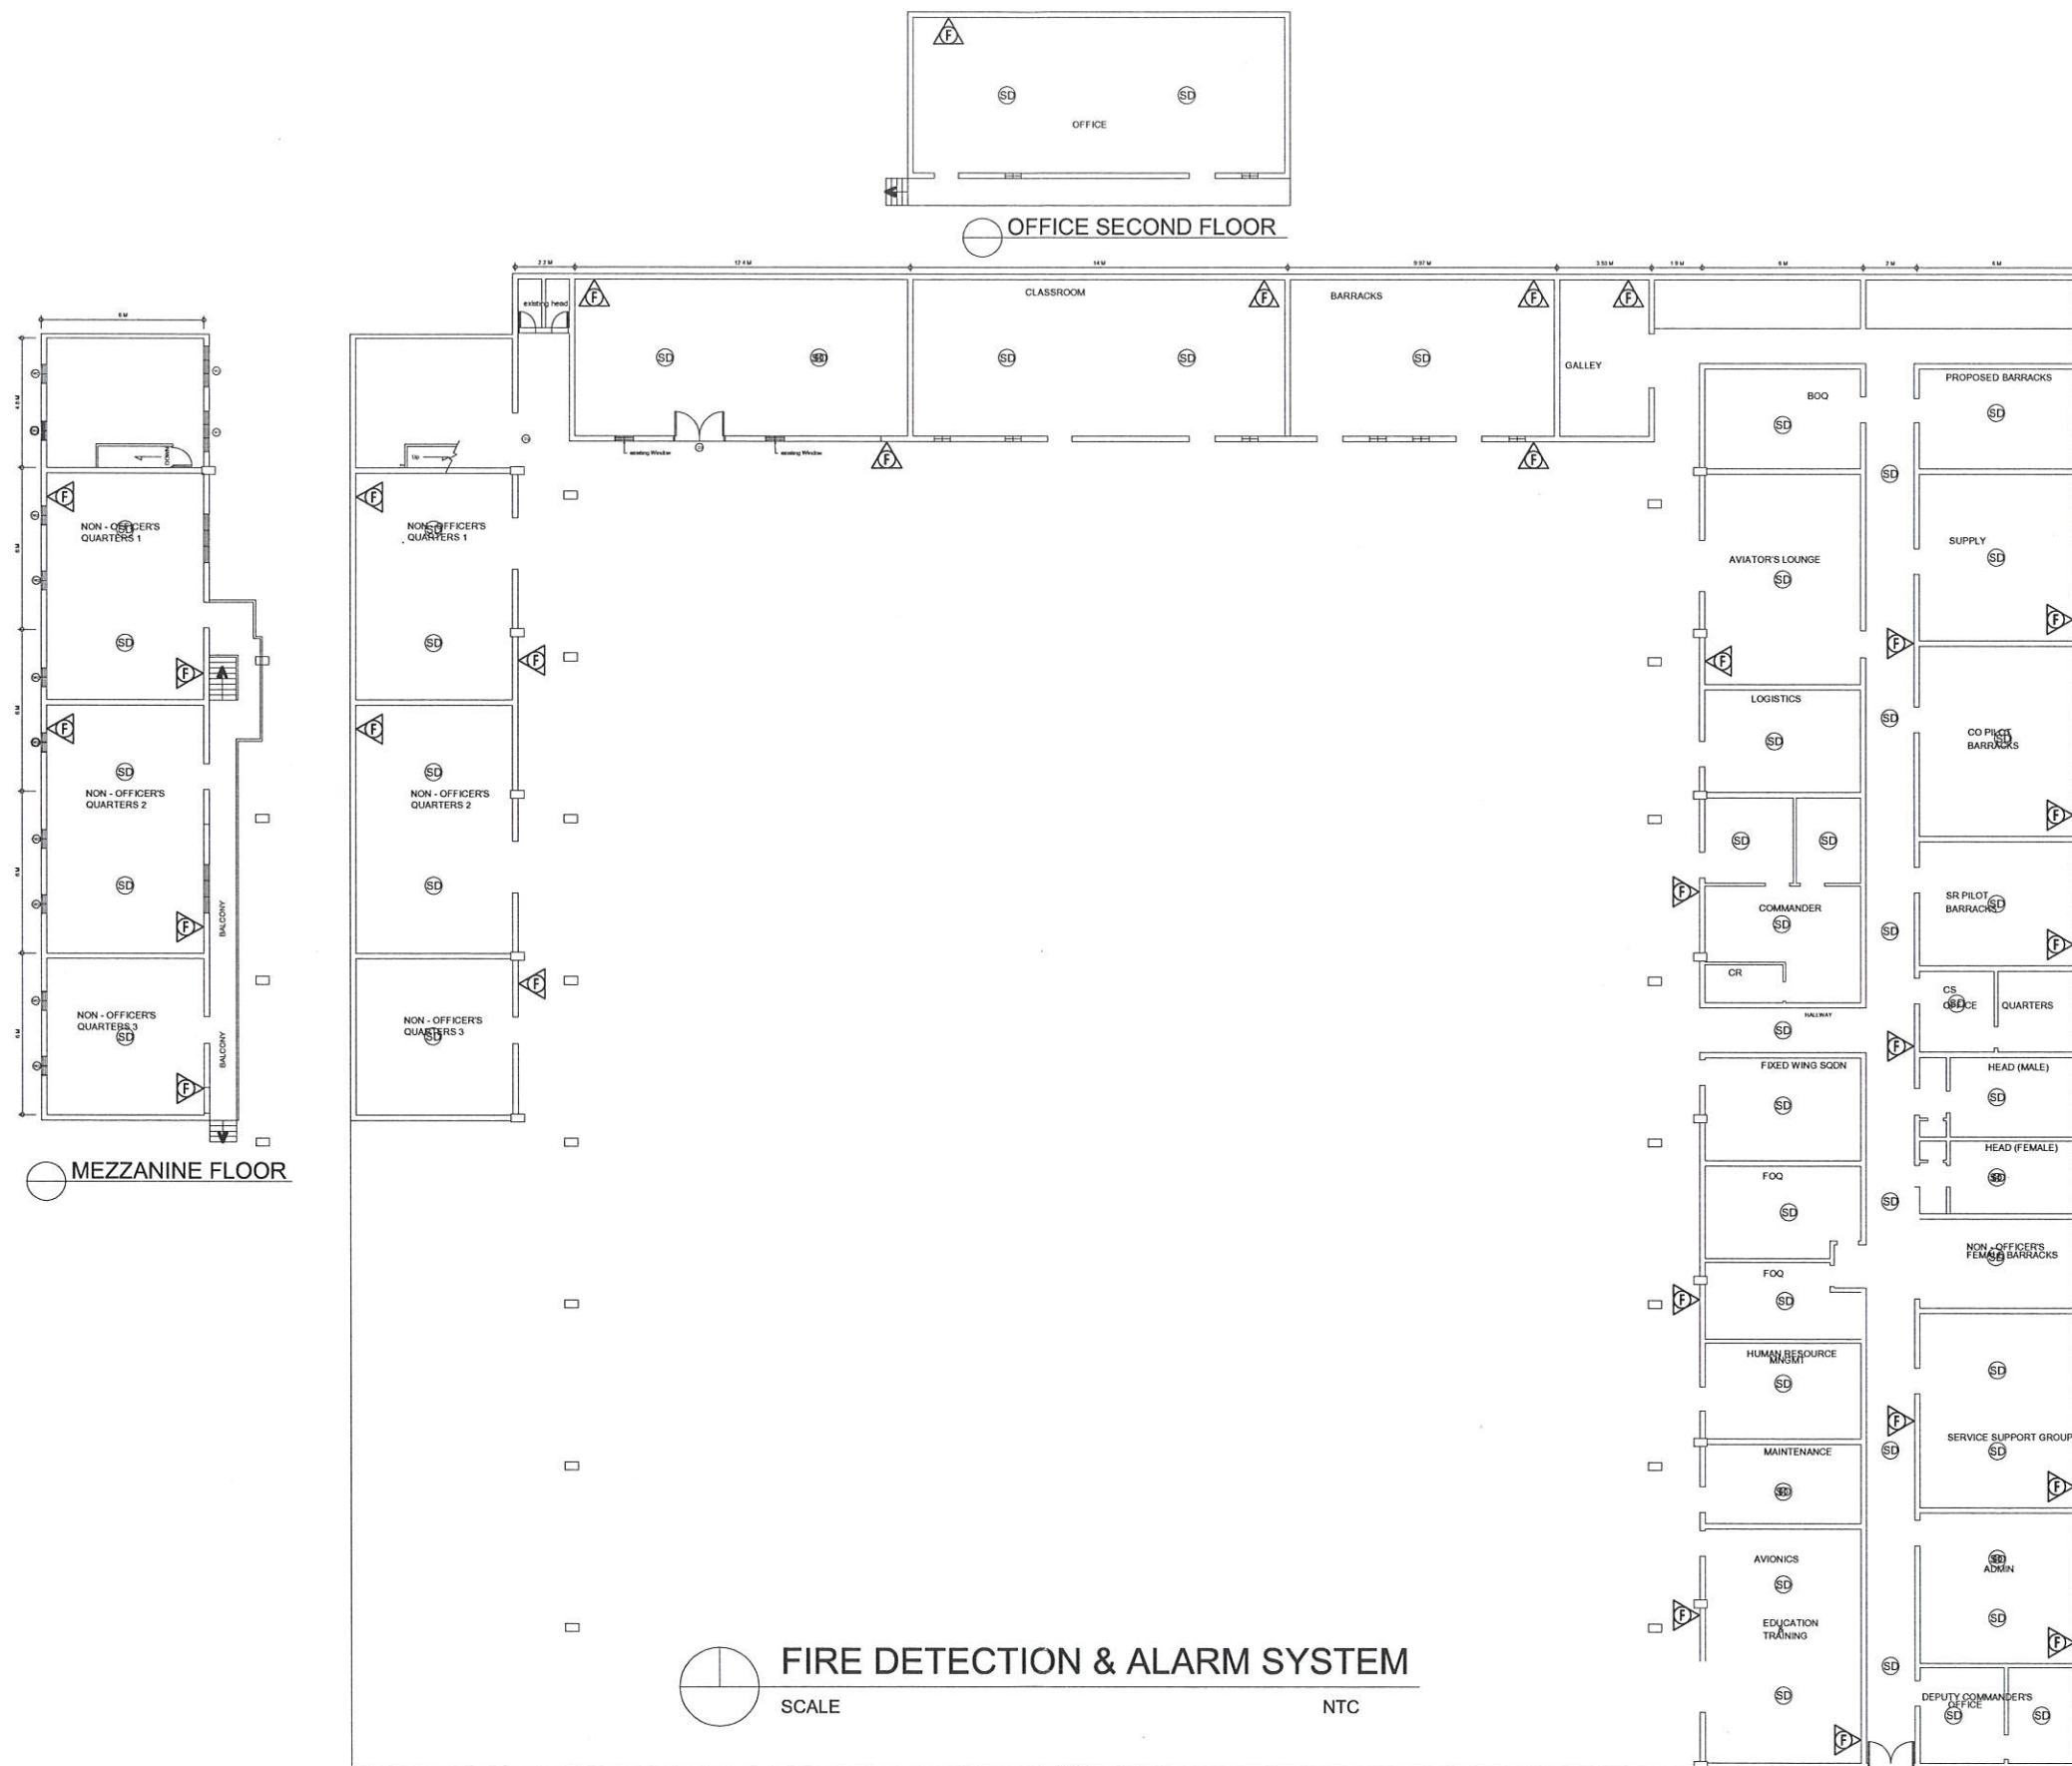

PHILIPPINE COAST GUARD
 HEADQUARTERS PHILIPPINE COAST GUARD
 139 25TH ST. PORT AREA MANILA
**COAST GUARD INFRASTRUCTURE
 DEVELOPMENT SERVICE**

PROJECT TITLE : REWIRING / UPGRADING OF CGAG ELECTRICAL SYSTEM
 LOCATION : DOTC Hangar Domestic Airport Complex, Pasay City
 OWNER : PHILIPPINE COAST GUARD

PREPARED BY:
 REVISION DATE
 REVALIDATION 19 MAR '19

CHECKED BY:


RECOMMENDED BY:

HILARIO A. ADAYA, REE
 Engineer IV, CGIDS

APPROVED BY:

CDR LAUREL PAUL N MARIANO JR PCG
 Commander, CGIDS

SHEET NO.

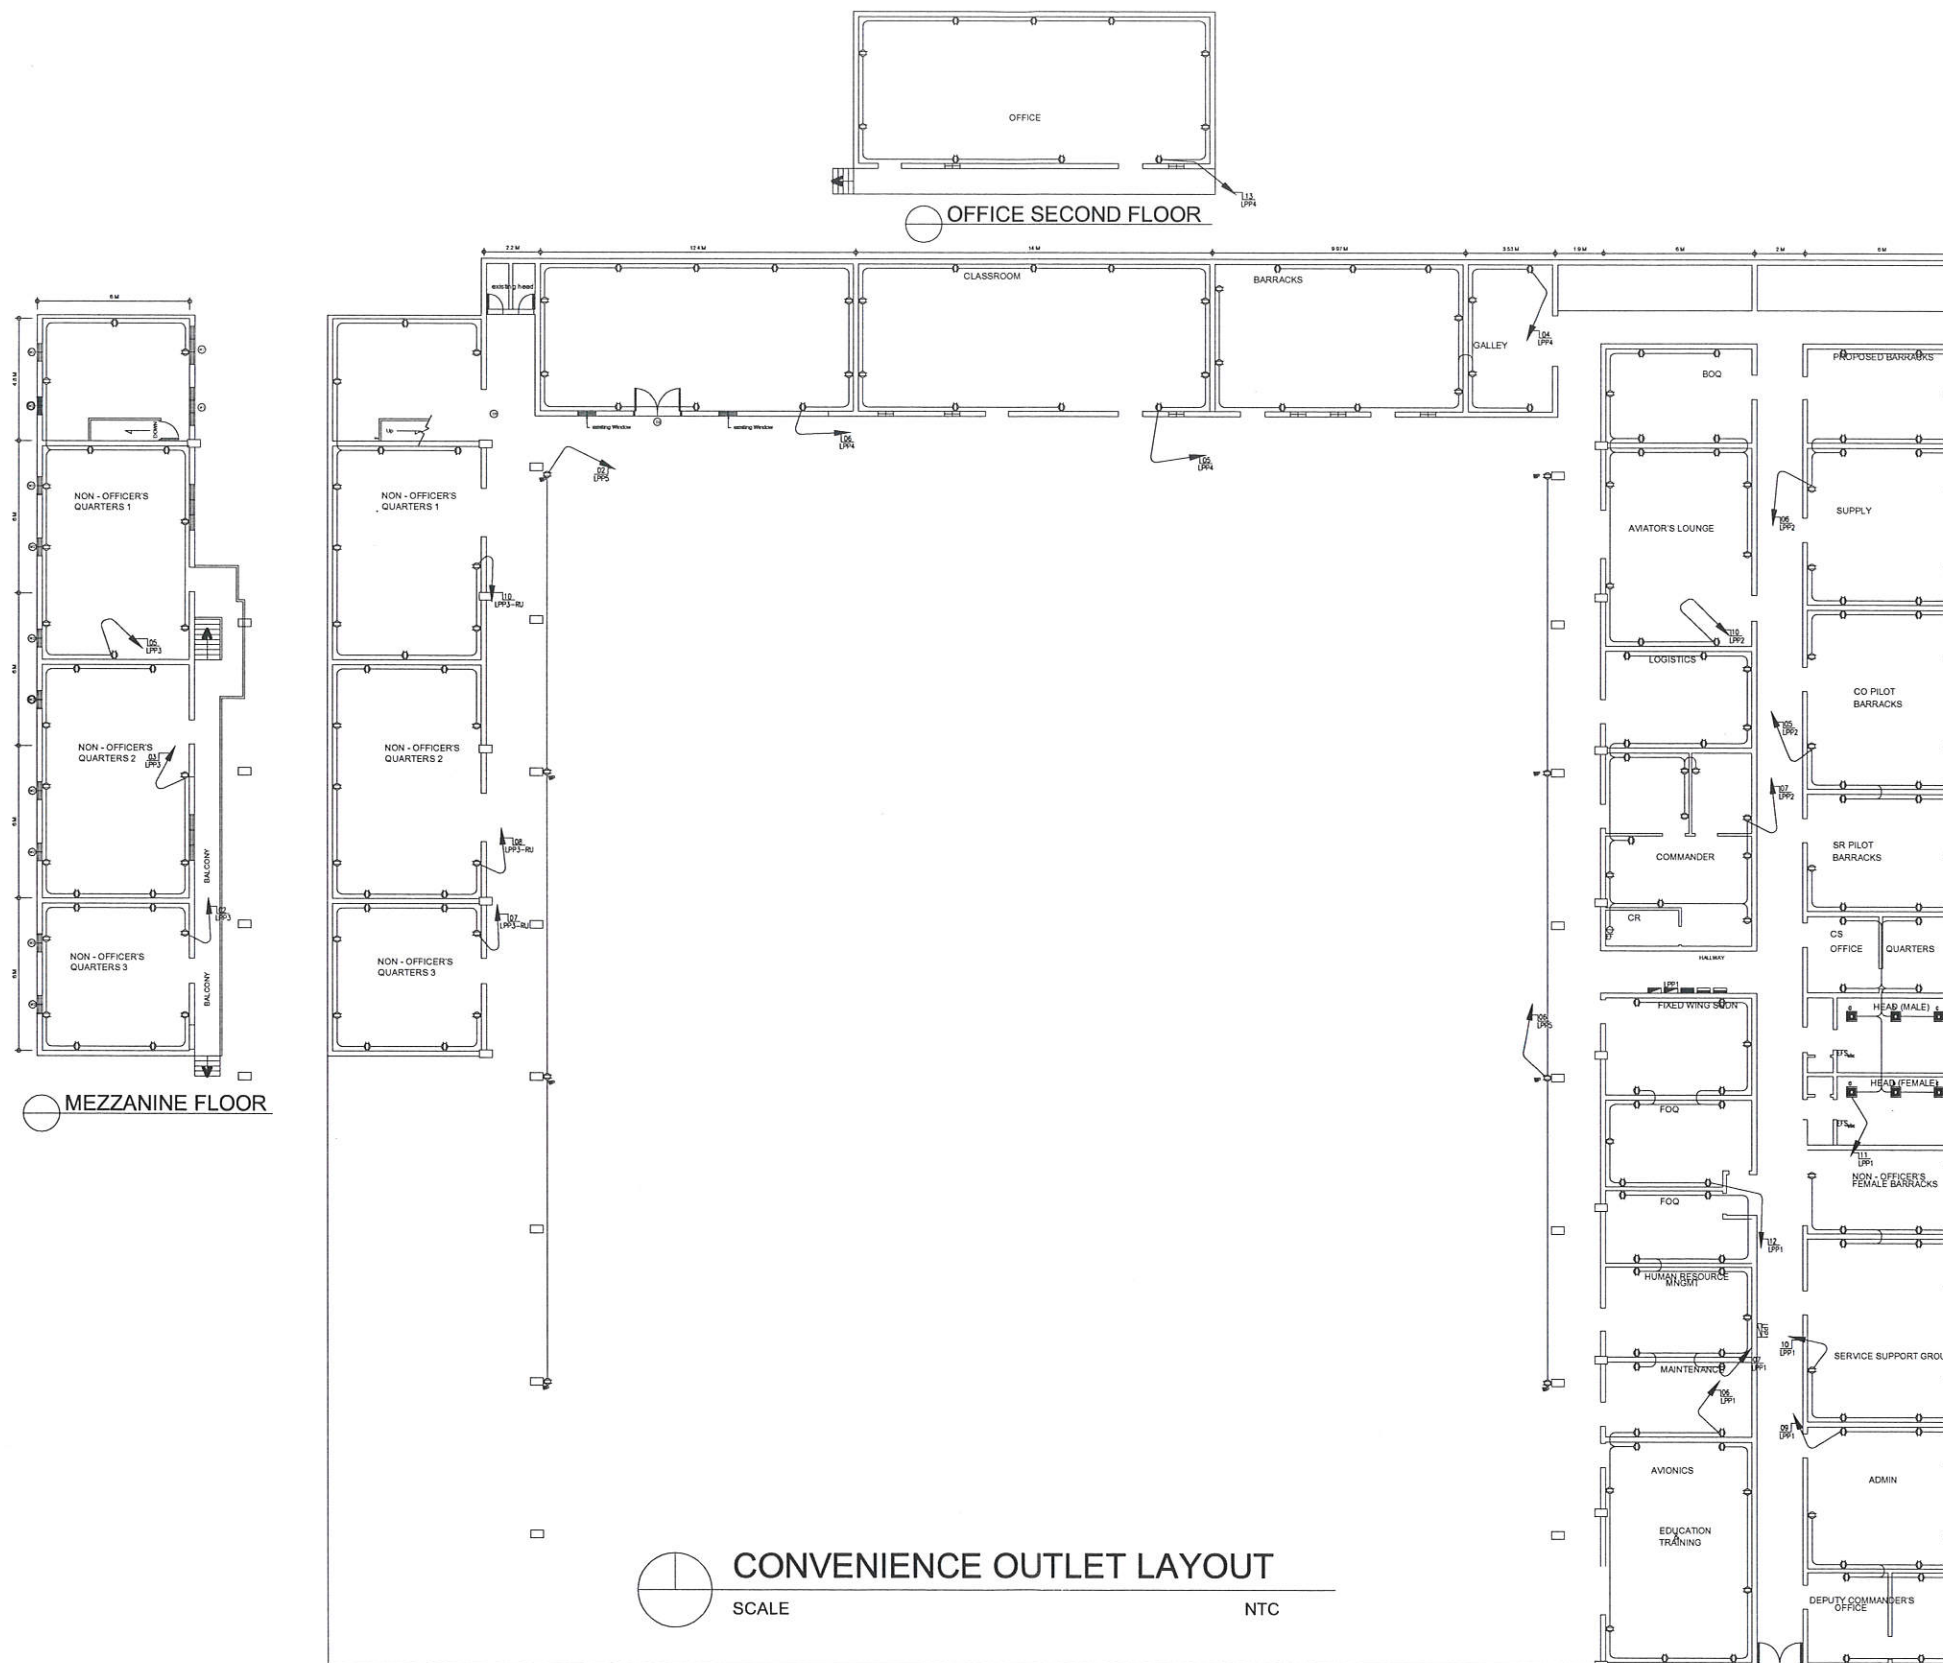

CONVENIENCE OUTLET LAYOUT

SCALE

NTC



PHILIPPINE COAST GUARD

HEADQUARTERS PHILIPPINE COAST GUARD
139 25TH ST. PORT AREA MANILA

COAST GUARD INFRASTRUCTURE
DEVELOPMENT SERVICE

PROJECT TITLE : REWIRING / UPGRADING OF CGAG ELECTRICAL SYSTEM
LOCATION : DOTC Hangar Domestic Airport Complex, Pasay City
OWNER : PHILIPPINE COAST GUARD

PREPARED BY:

CHECKED BY:

RECOMMENDED BY:

APPROVED BY:

REVISION

DATE


REVALIDATION

19 MAR '19

HILARIO A. ADAYA, REE
Engineer IV, CGIDS

CDR LAUREL PAUL M. MARIANO JR PCG
Commander, CGIDS

SHEET NO.

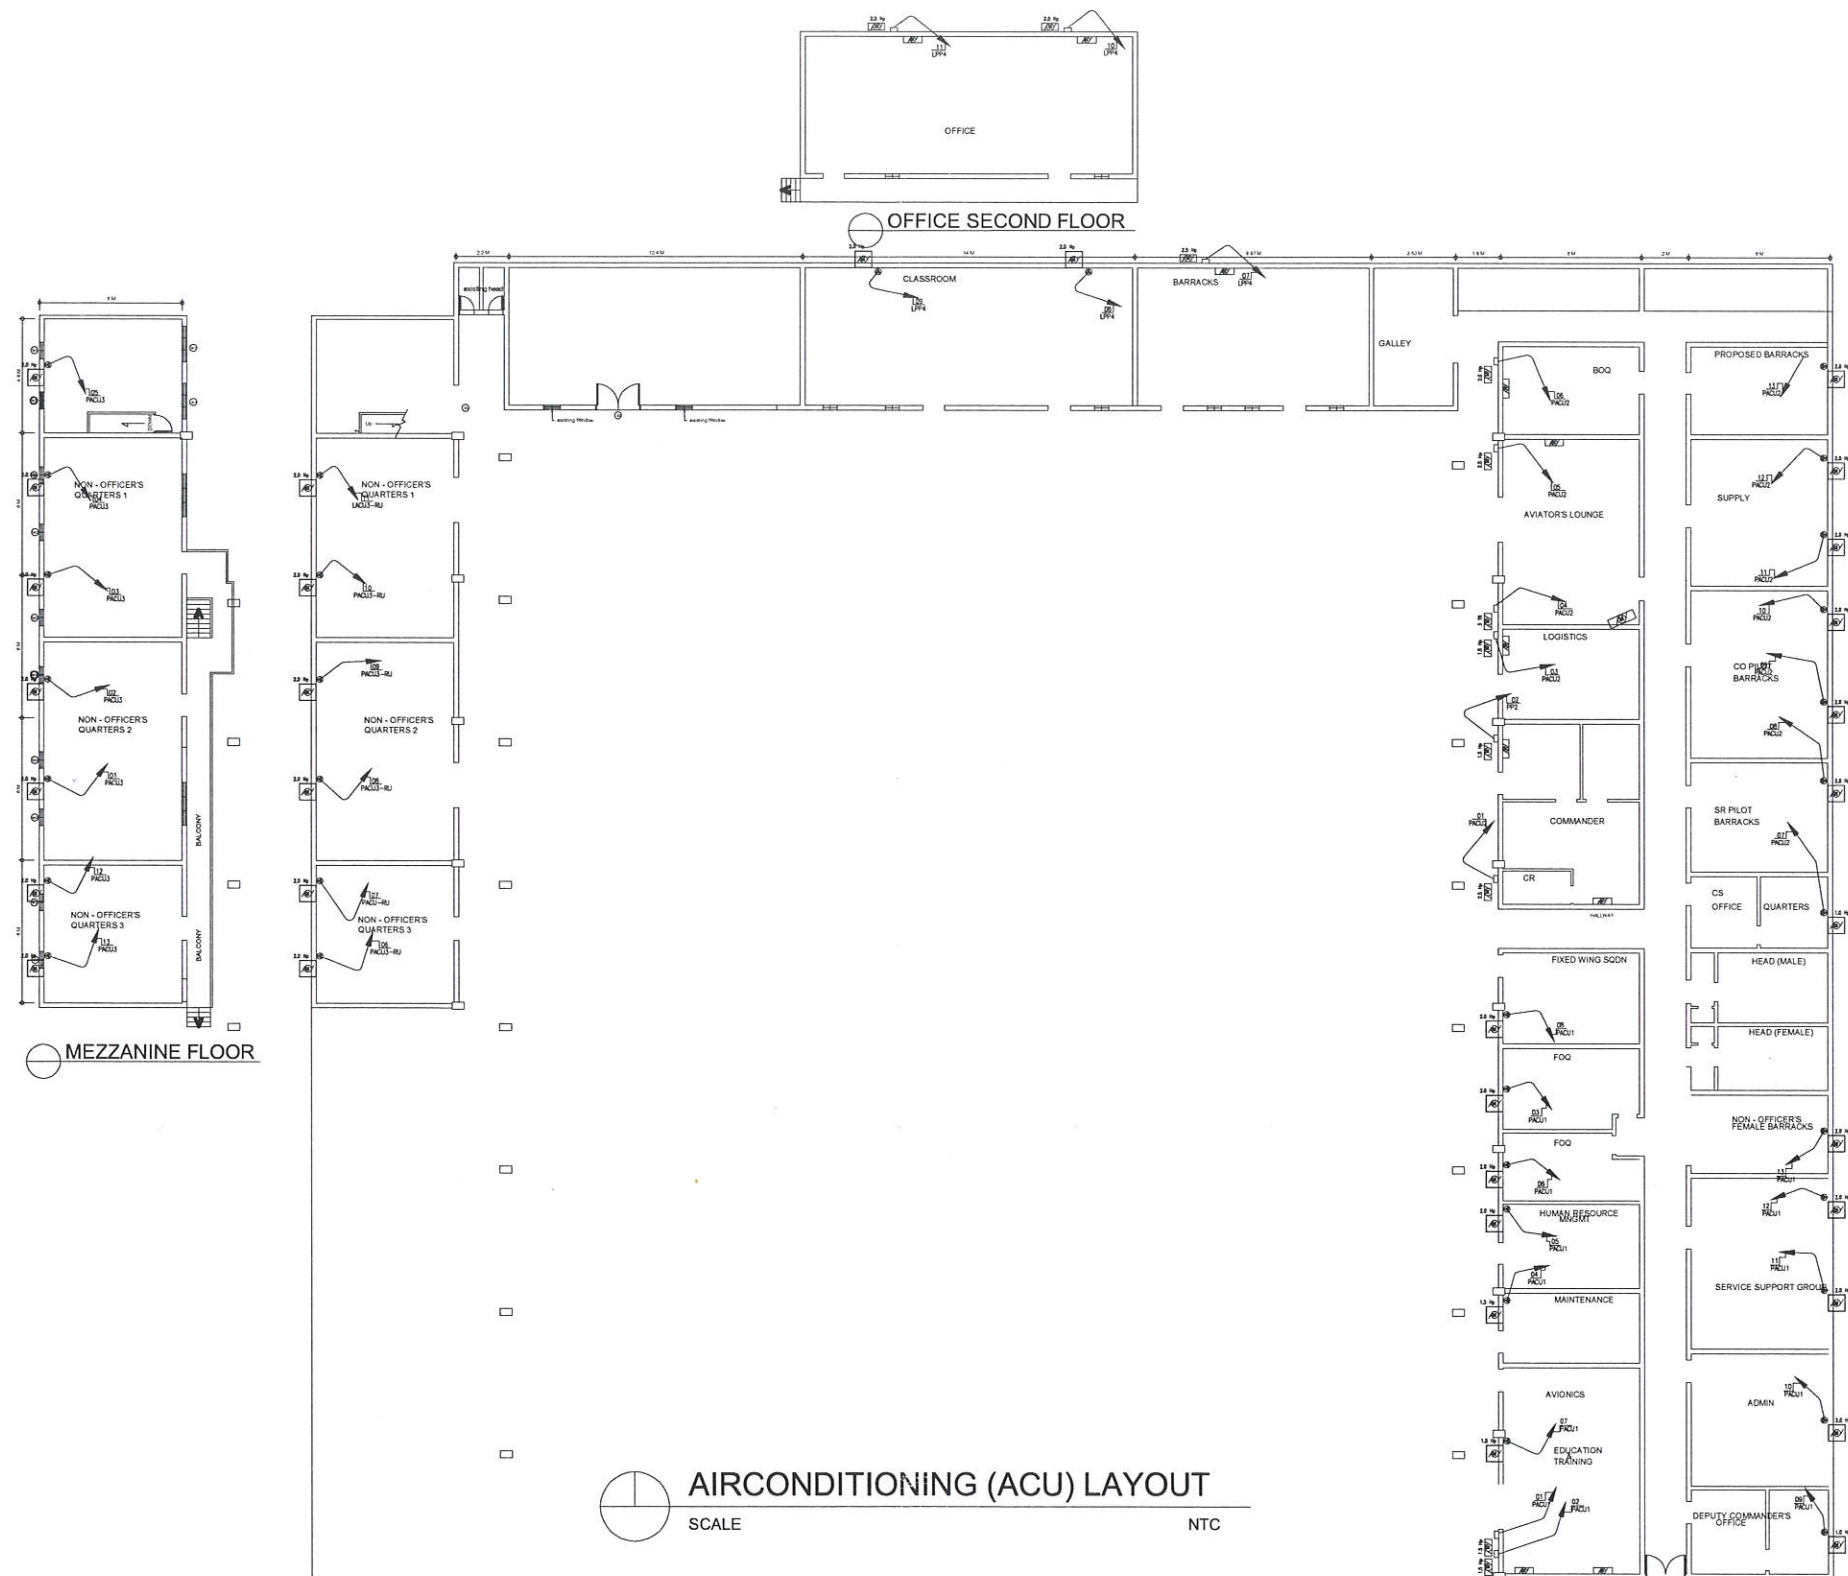

PHILIPPINE COAST GUARD

HEADQUARTERS PHILIPPINE COAST GUARD
139 25TH ST. PORT AREA MANILA

**COAST GUARD INFRASTRUCTURE
DEVELOPMENT SERVICE**

PROJECT TITLE : REWIRING / UPGRADING OF CGAG ELECTRICAL SYSTEM
LOCATION : DOTC Hangar Domestic Airport Complex, Pasay City
OWNER : PHILIPPINE COAST GUARD

PREPARED BY:

CHECKED BY:

RECOMMENDED BY:


APPROVED BY:

REVISION	DATE
REVALIDATION	19 MAR '19

HILARIO A. ADAYA, REE
Engineer IV, CGIDS

CDR LAUREL PAUL N MARIANO JR PCG
Commander, CGIDS

SHEET NO.

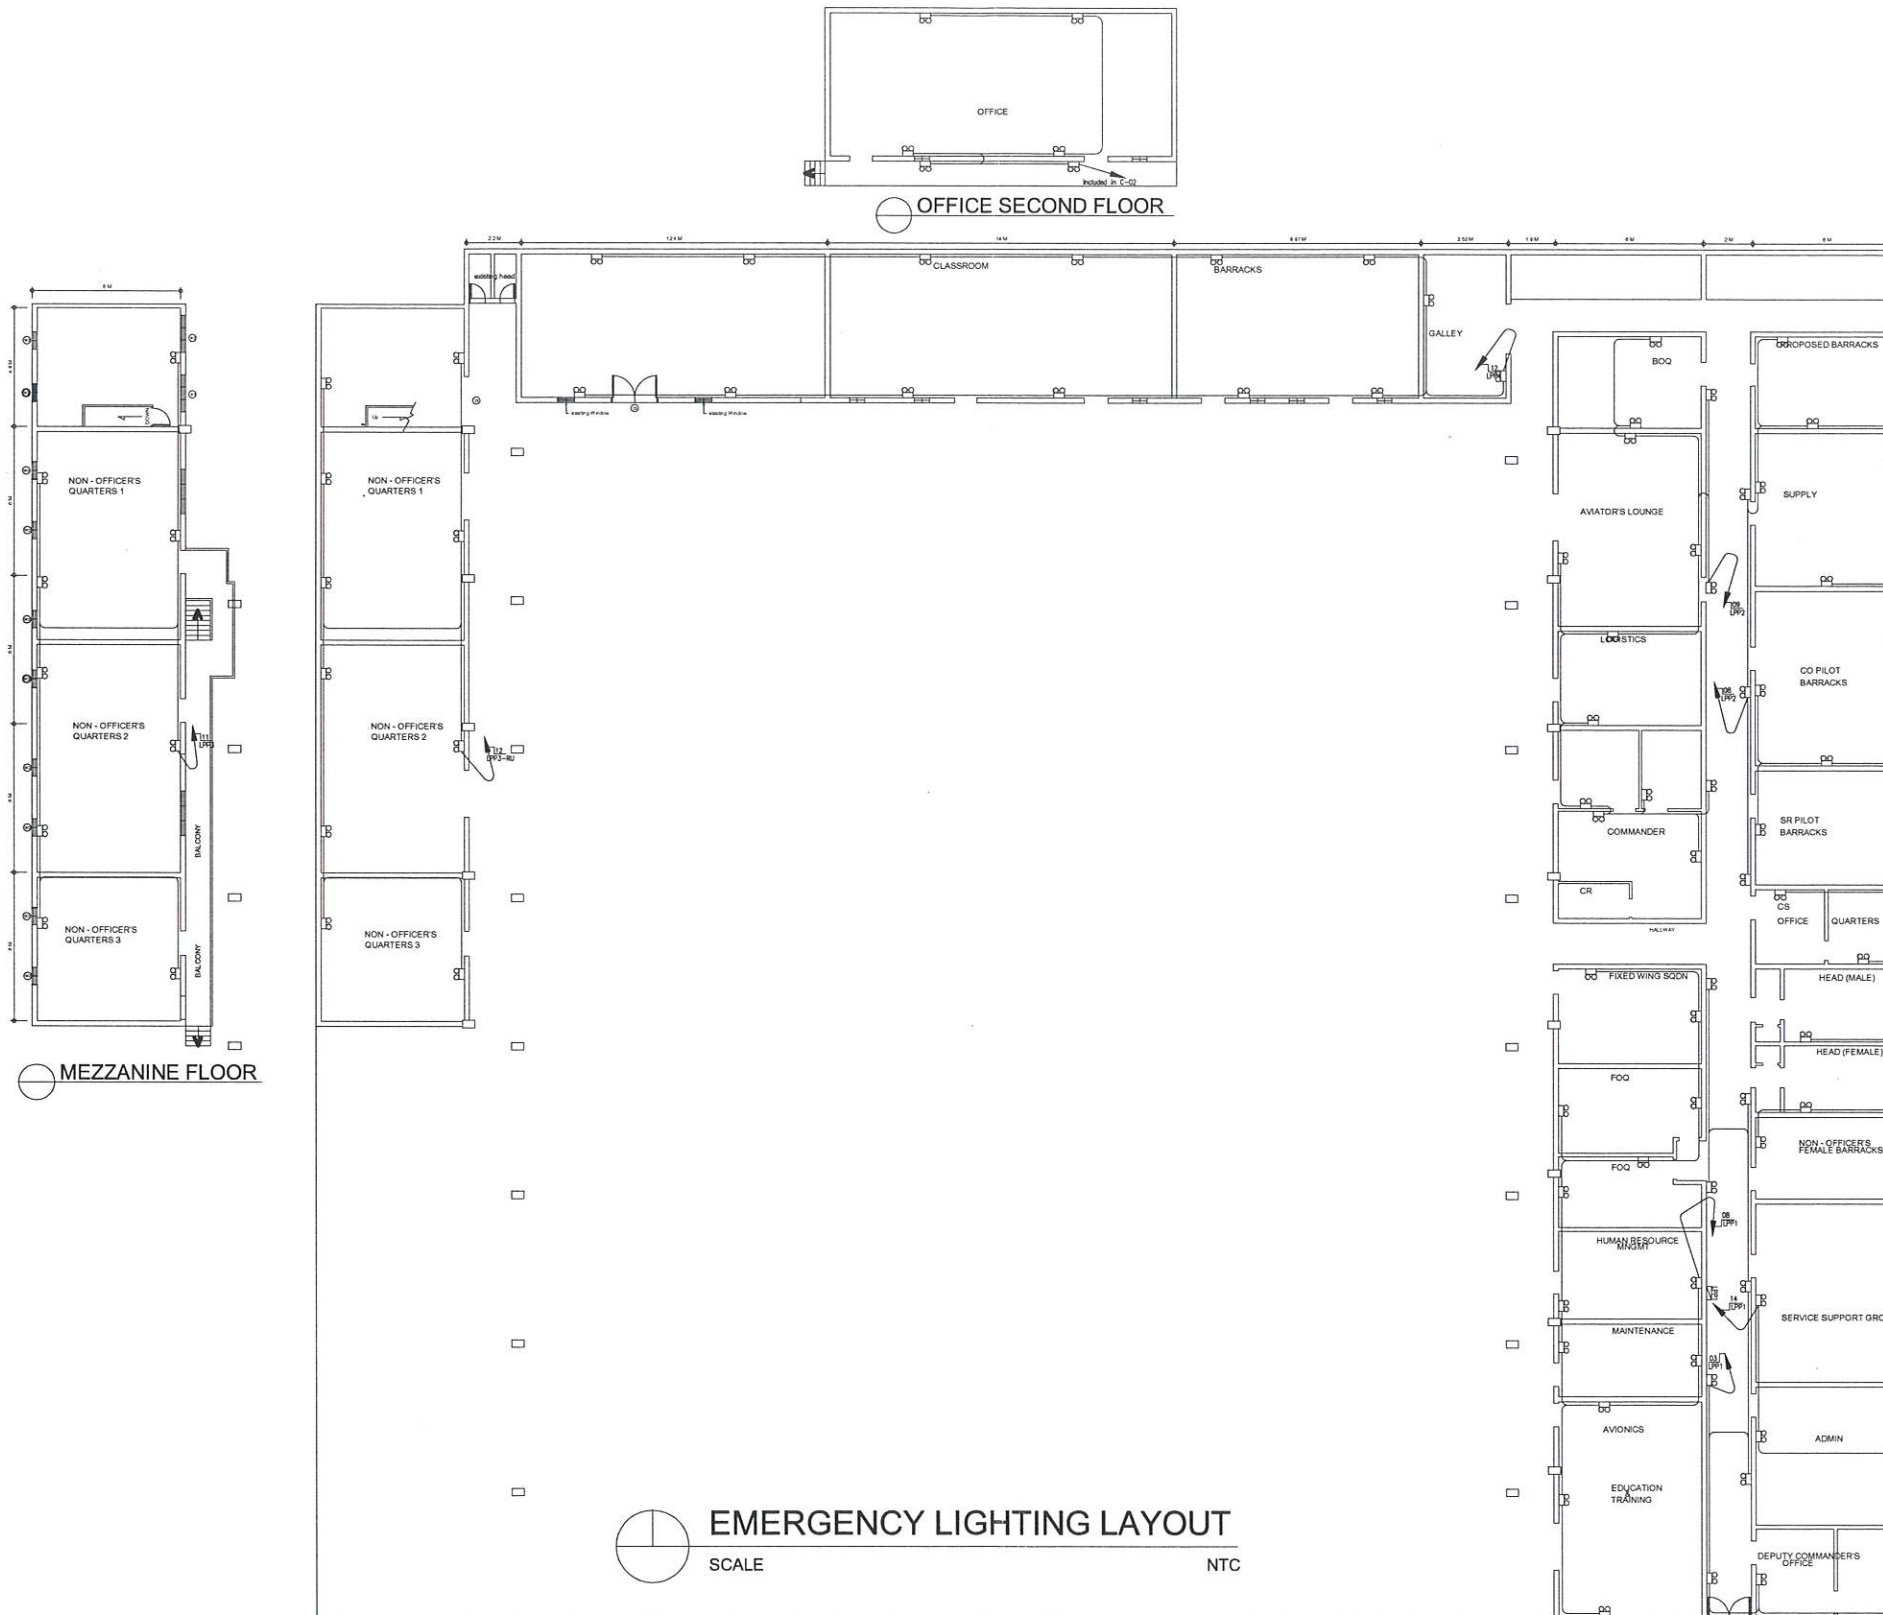

PHILIPPINE COAST GUARD
HEADQUARTERS PHILIPPINE COAST GUARD
139 25TH ST. PORT AREA MANILA
**COAST GUARD INFRASTRUCTURE
DEVELOPMENT SERVICE**

PROJECT TITLE : REWIRING / UPGRADING OF CGAG ELECTRICAL SYSTEM
LOCATION : DOTC Hangar Domestic Airport Complex, Pasay City
OWNER : PHILIPPINE COAST GUARD

PREPARED BY:

CHECKED BY:

RECOMMENDED BY:


APPROVED BY:

REVISION	DATE
REVALIDATION	19 MAR '19

HILARIO A. ADAYA, REE
Engineer IV, CGIDS

CDR LAUREL PAUL N. MARIANO JR PCG
Commander, CGIDS

SHEET NO.

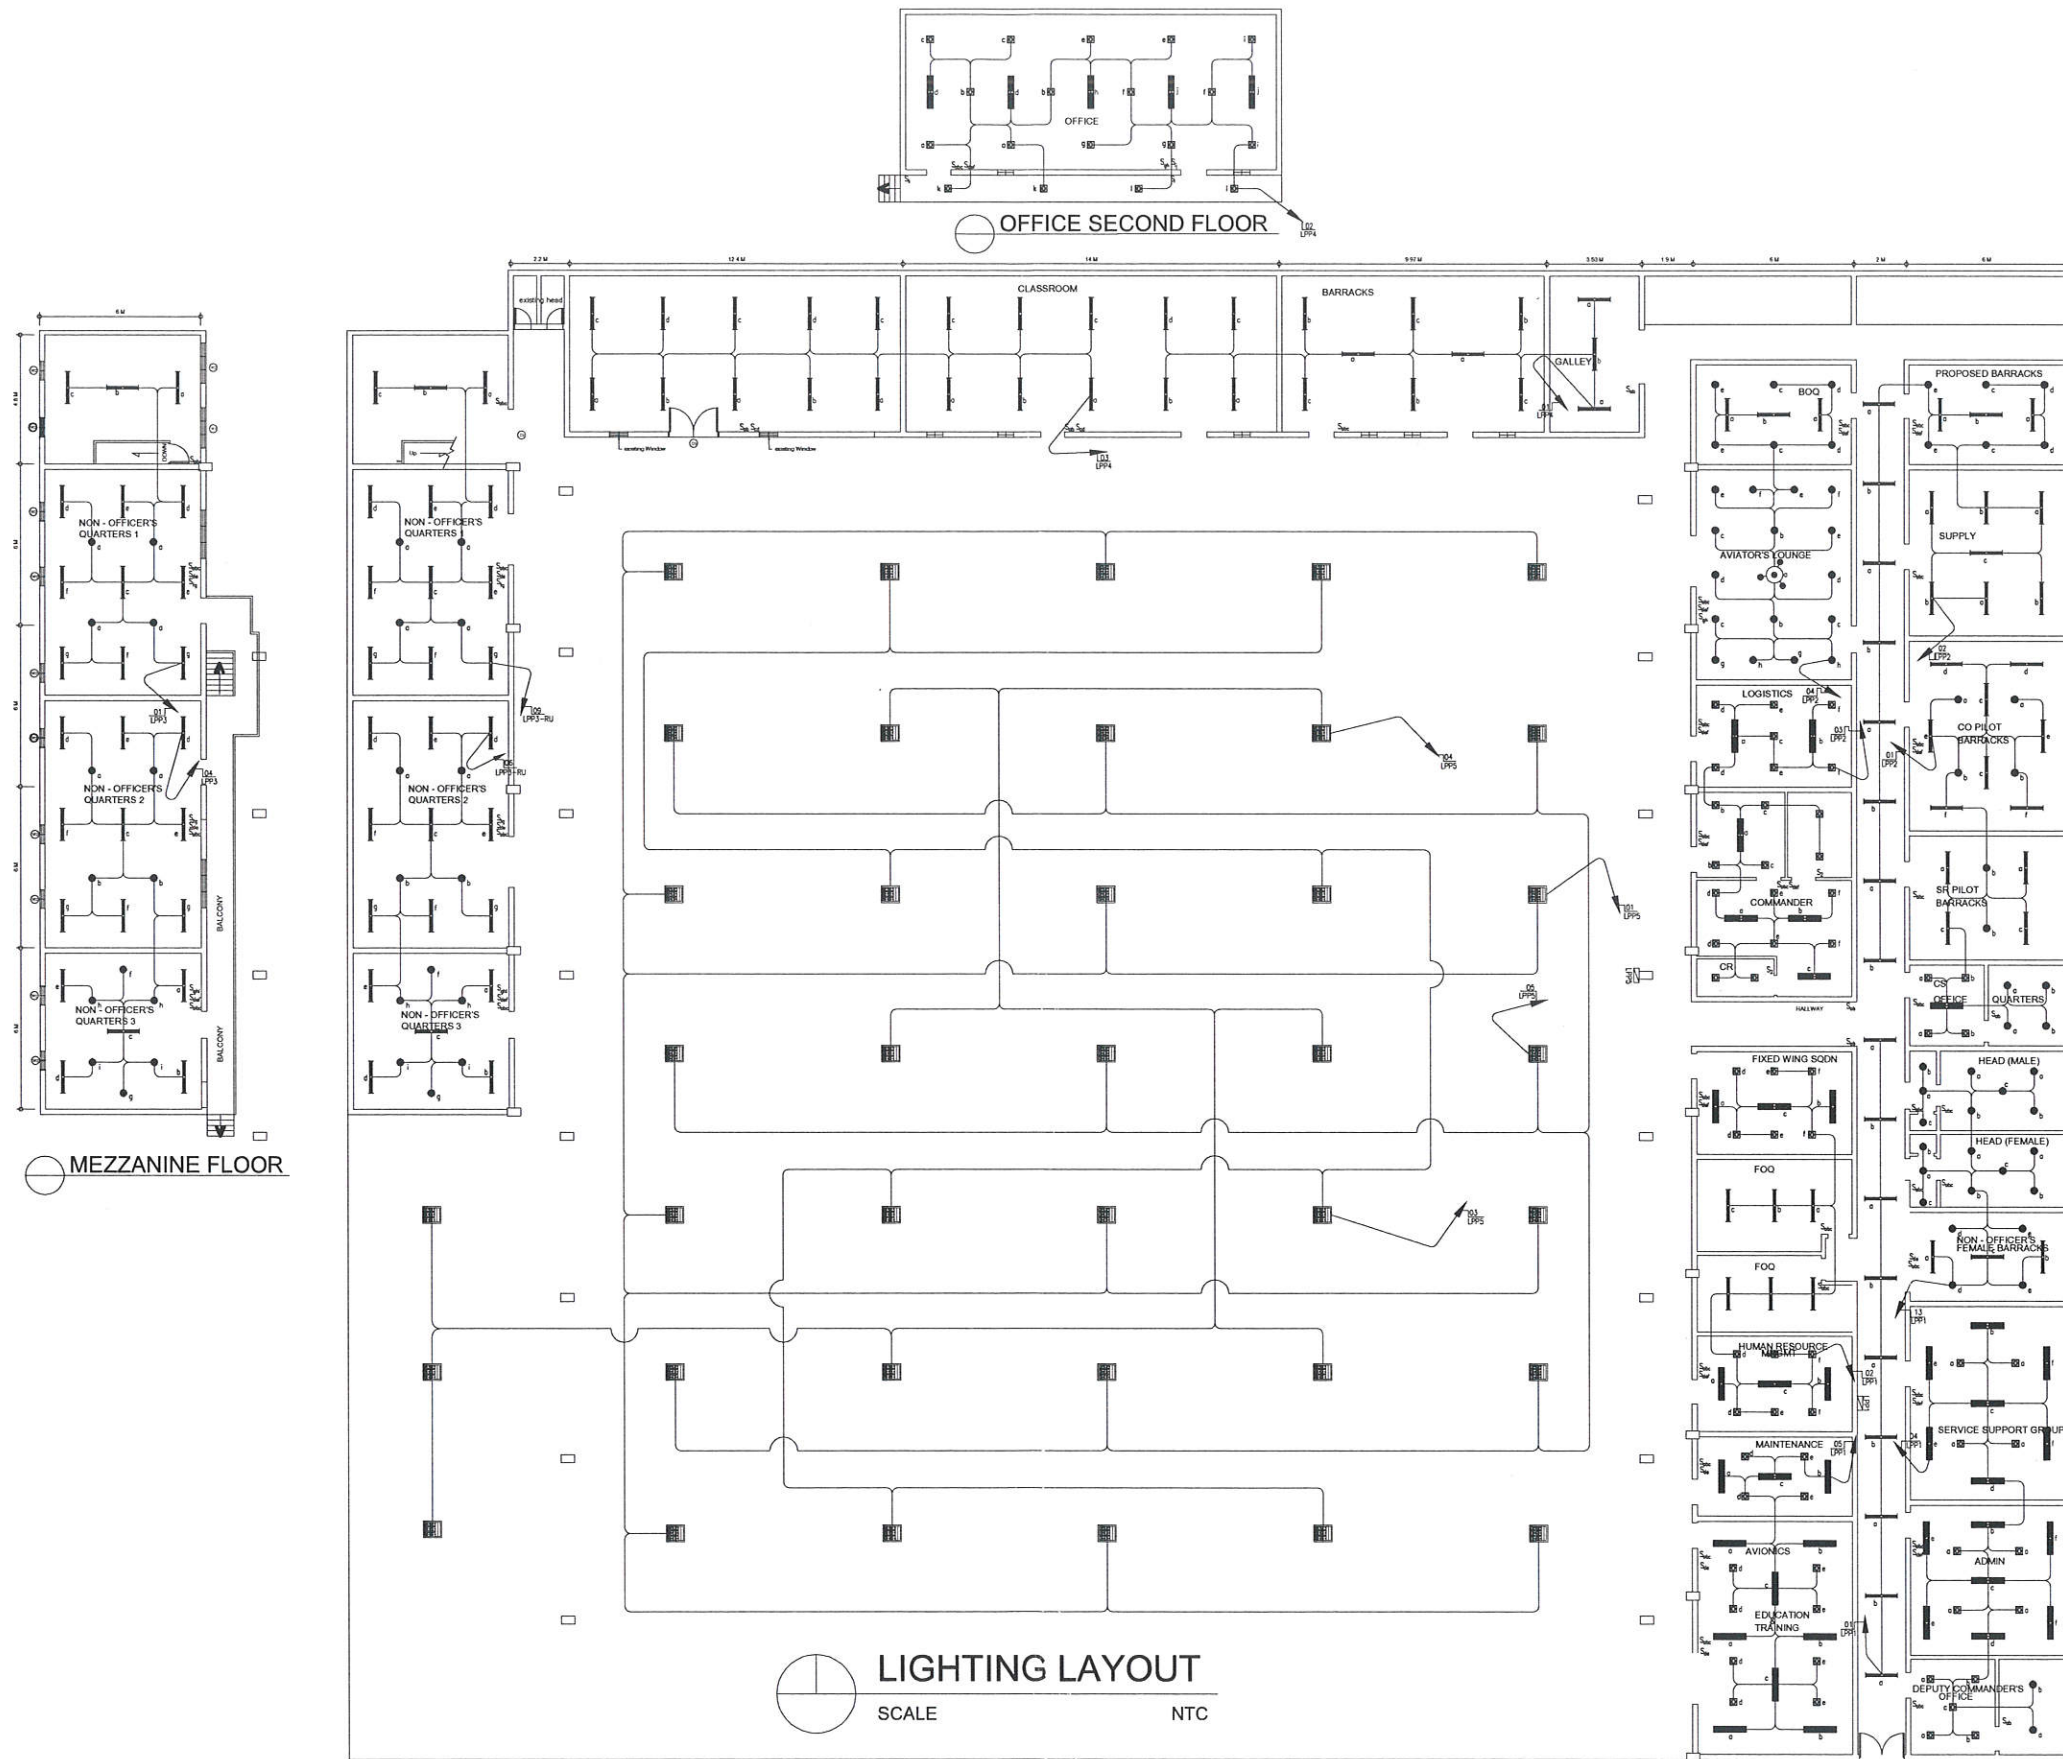

PHILIPPINE COAST GUARD

HEADQUARTERS PHILIPPINE COAST GUARD
139 25TH ST. PORT AREA MANILA

COAST GUARD INFRASTRUCTURE
DEVELOPMENT SERVICE

PROJECT TITLE : REWIRING / UPGRADING OF CGAG ELECTRICAL SYSTEM
LOCATION : DOTC Hangar Domestic Airport Complex, Pasay City
OWNER : PHILIPPINE COAST GUARD

PREPARED BY:

CHECKED BY:

RECOMMENDED BY:

APPROVED BY:

REVISION

DATE


REVALIDATION

19 MAR '19

HILARIO A. ADAYA, REE
Engineer IV, CGIDS

CDR LAUREL PAUL N. MARIANO JR PCG
Commander, CGIDS

SHEET NO.

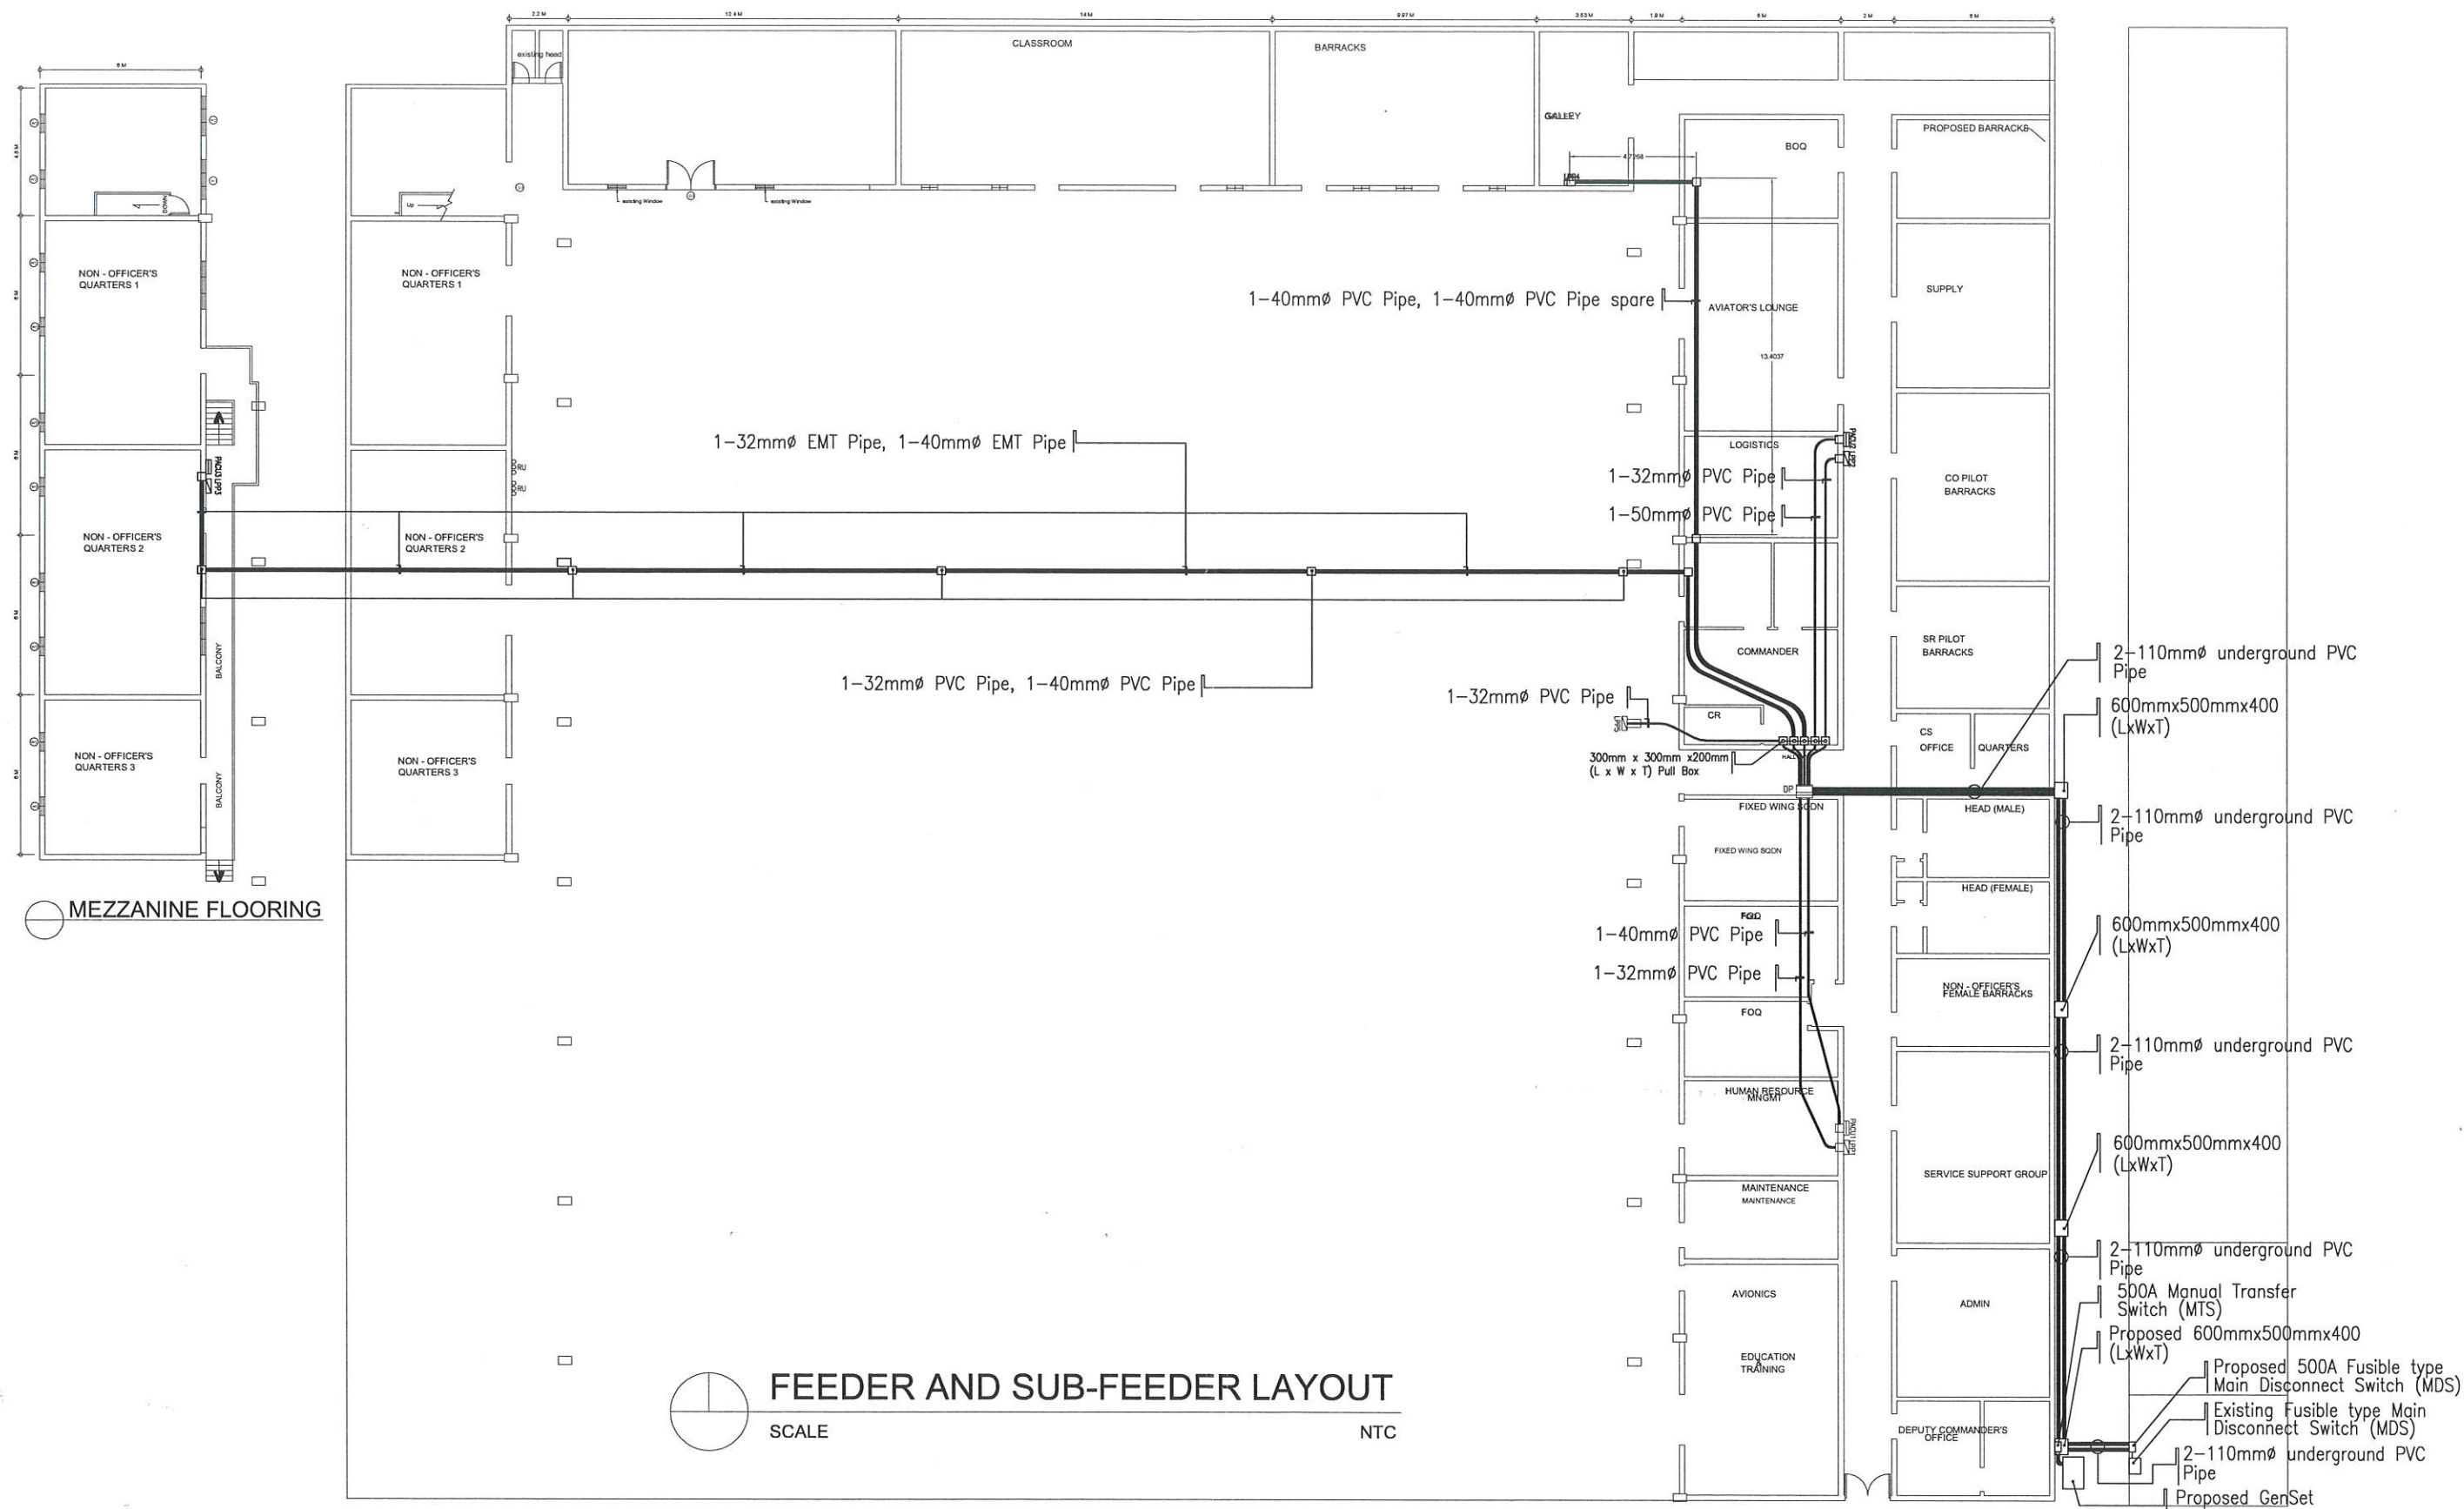

PHILIPPINE COAST GUARD
HEADQUARTERS PHILIPPINE COAST GUARD
139 25TH ST. PORT AREA MANILA
**COAST GUARD INFRASTRUCTURE
DEVELOPMENT SERVICE**

PROJECT TITLE : REWIRING / UPGRADING OF CGAG ELECTRICAL SYSTEM
LOCATION : DOTC Hangar Domestic Airport Complex, Pasay City
OWNER : PHILIPPINE COAST GUARD

PREPARED BY:

CHECKED BY:

RECOMMENDED BY:

APPROVED BY:

REVISION

DATE

REVALIDATION

19 MAR '19

HILARIO A. ADAYA, REE
Engineer IV, CGIDS

CDR LAUREL PAUL M. MARIANO JR PCG
Commander, CGIDS

SHEET NO.